
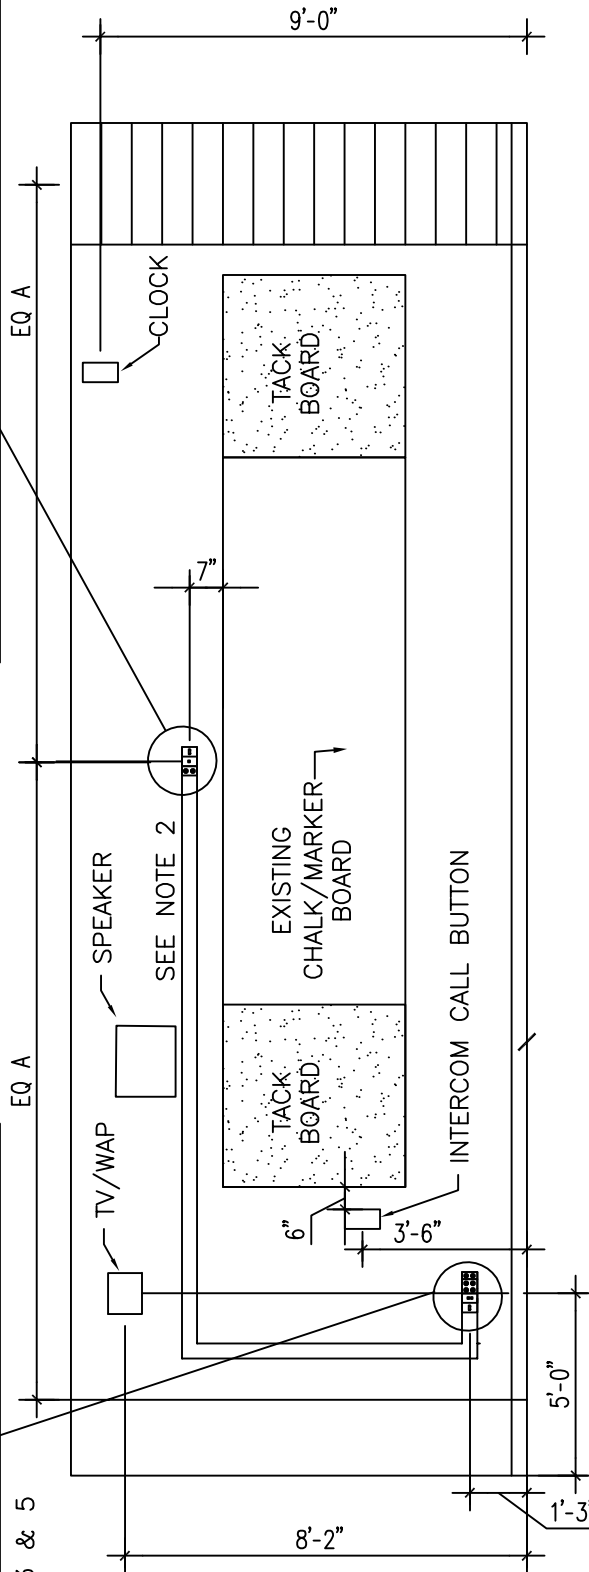
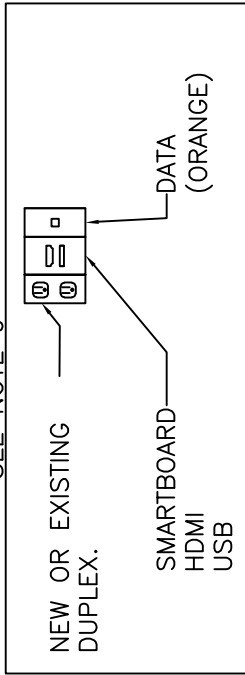


REFER TO DETAIL ED.806

SEE NOTE 9

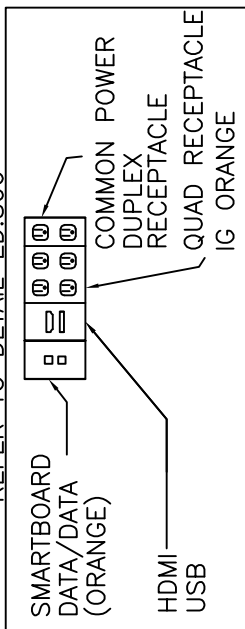

NOTE

1. CONNECT NEW DATA OUTLETS TO CONCENTRATOR SERVING CLASSROOM.
2. SMARTBOARD PROVISIONS. PROVIDE NEW OR EXTEND EXISTING SURFACE MOUNTED STEEL RACEWAY WITH HDMI CABLE TO TEACHER STATION OUTLET. TERMINATE HDMI CABLE ON FACEPLATE AT EACH END. REFER TO FLOOR PLANS.
3. TEACHERS STATION OUTLETS. LOCATE TEACHER STATION HDMI/USB OUTLET ADJACENT TO EXISTING TEACHER STATION RECEPTACLES. REFER TO FLOOR PLANS.
4. COLOR CODE CABLE AND JACKS.
5. LABEL FACEPLATE OR TEACHER STATION OUTLET "TO SMARTBOARD".
6. BACKBOXES SHALL BE OFFSET AND NOT MOUNTED BACK TO BACK.
7. IF TV/WAP, INTERCOM (CALL BUTTON & SPEAKER), CLOCK ARE NOT PRESENT OR WILL BE REMOVED, THEY ARE TO BE PROVIDED.
8. THE DUPLEX OUTLETS ASSOCIATED WITH TECHNOLOGY OUTLETS NEED TO BE GREY IN COLOR AND ROUTED TO TECHNOLOGY "ONLY" ELECTRICAL PANELS FOR NEW CONSTRUCTION ONLY. EXISTING SCHOOLS WHERE ISOLATED GROUND (IG) EXIST OUTLETS SHOULD REMAIN 'IG' AND ORANGE.
9. REFER TO DETAIL ED.011A FOR HUBBELL PART NUMBERS FOR POWER RECEPTACLE, HDMI AND USB OUTLETS.



CHICAGO PUBLIC SCHOOLS CAPITAL IMPROVEMENT PROGRAM INFORMATION TECHNOLOGY SERVICES INFRASTRUCTURE STANDARDS

TYPICAL CLASSROOM TEACHING WALL – RENOVATION

NO.	DATE	REVISION	BY

DESIGNED CPS
DRAWN CPS
CHECKED CPS
APPROVED CPS

PROJECT NUMBER	SCALE NTS	DATE 06/01/24
----------------	--------------	------------------

SHEET NO. ED.301B
